

CLIENT
 WESLACO INDEPENDENT SCHOOL DISTRICT

PROJECT NUMBER
 19261M

DATE: 08/18/2020

DRAWN BY: MATT TREVINO


CHECKED BY: TAE HWANG

REVISIONS

No.	Description	Date
1	Addendum #01	08/25/2020
2	Addendum #02	08/31/2020

100% CONSTRUCTION DOCUMENTS
GAS PIPING PLAN

ME2.03

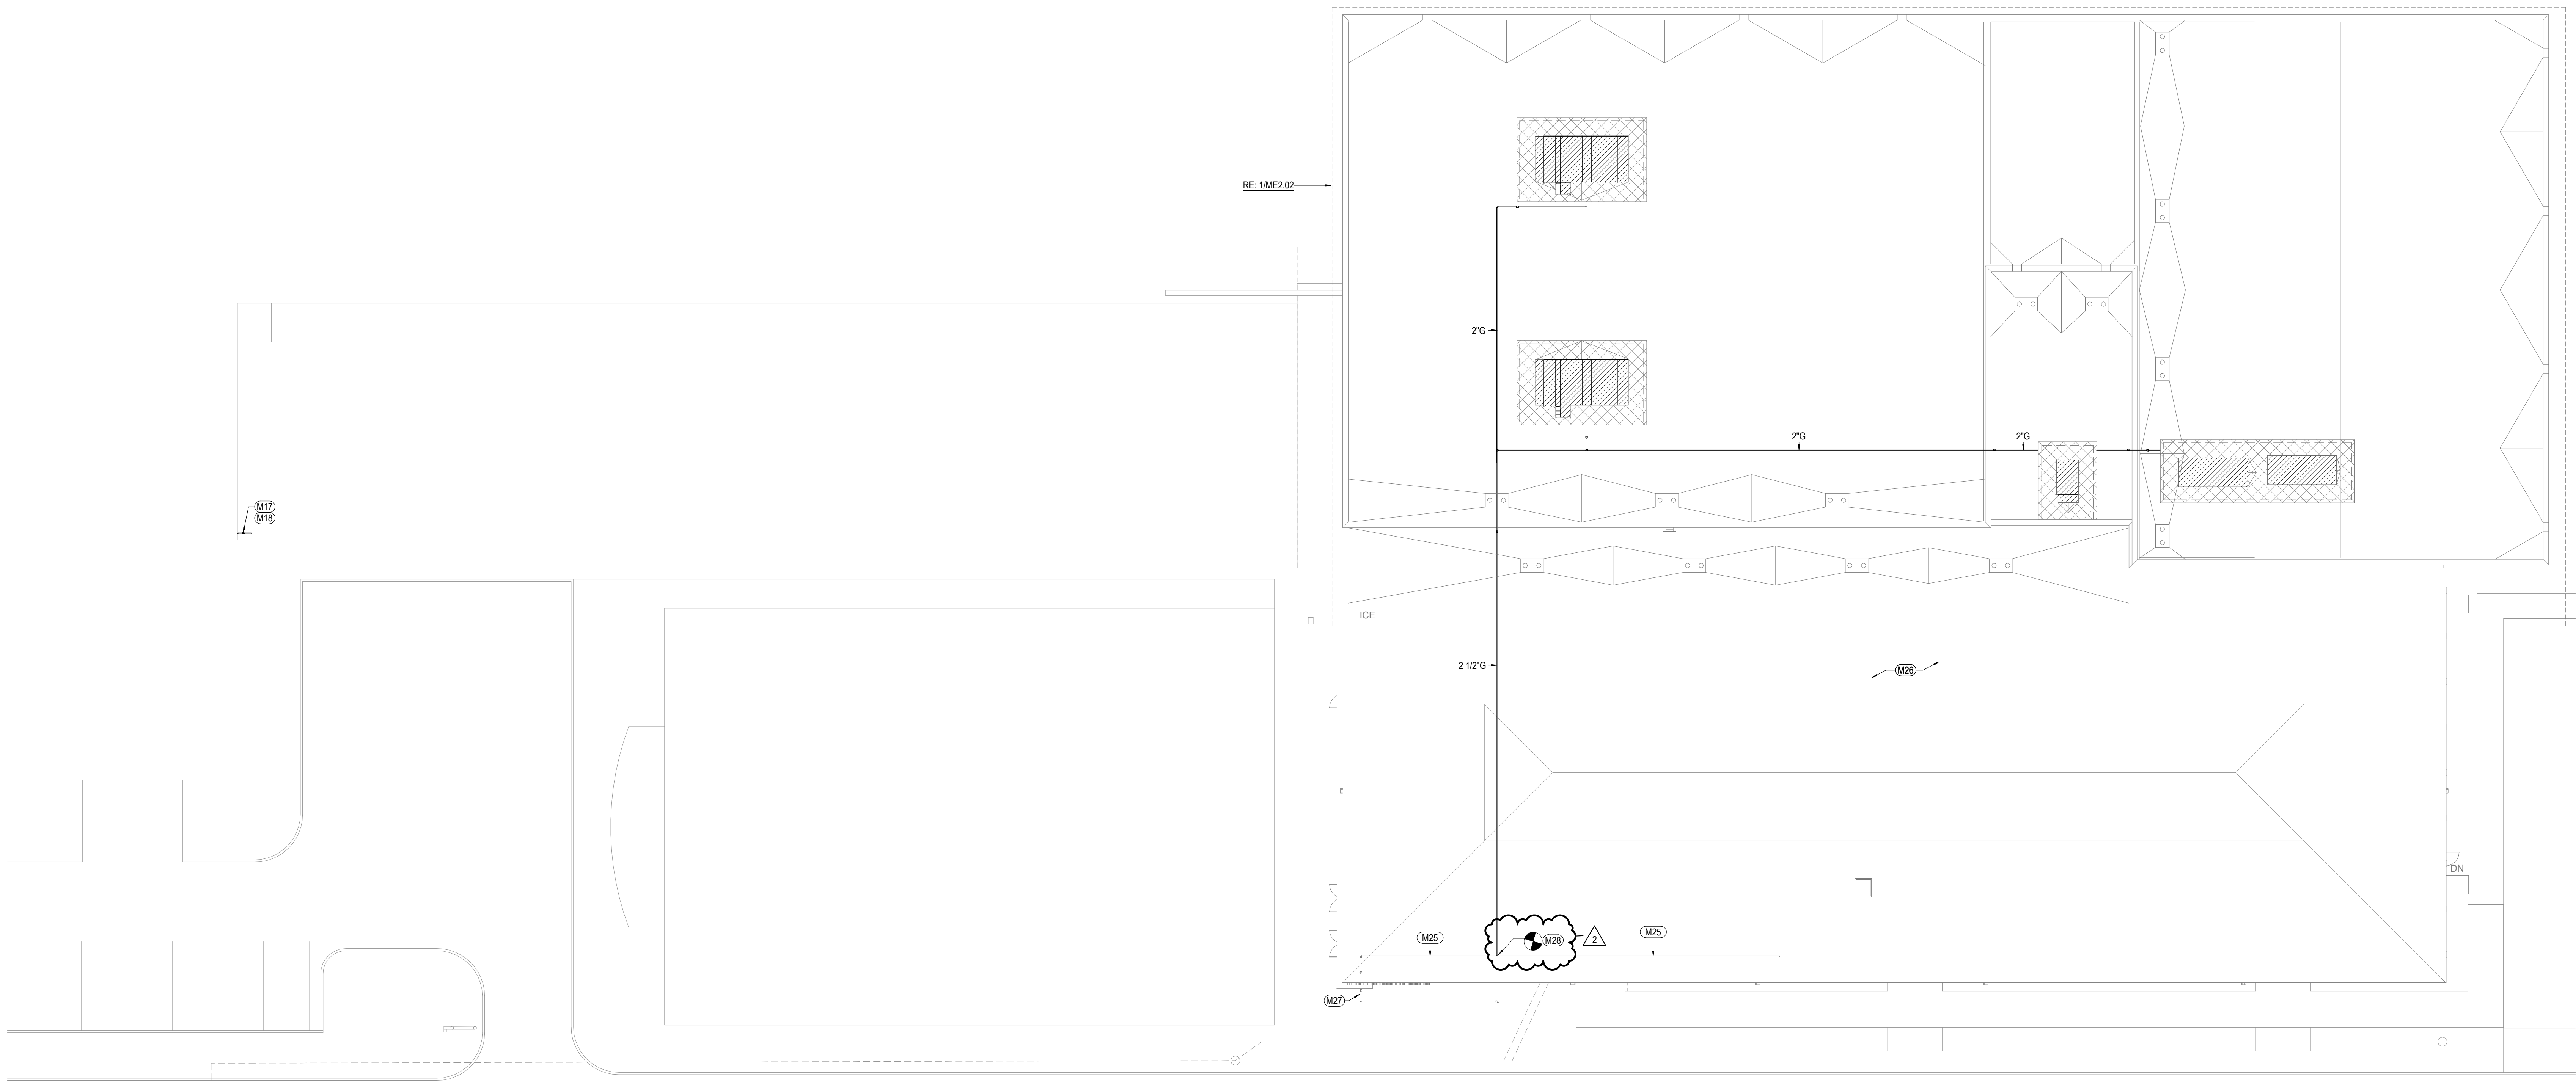

1 GAS PIPING PLAN
 SCALE: 1/16" = 1'-0"

KEYED NOTES - MECHANICAL PLAN

- M17 FIELD VERIFY LOCATION OF EXISTING GAS METER TO BUILDING.
- M18 CONTRACTOR TO REQUEST GAS PRESSURE. BE INCREASED FROM GAS SUPPLIER TO 2PSI. CONTRACTOR TO VERIFY ALL BRANCH PIPING FROM METER TO BUILDINGS AND PROVIDE GAS PRESSURE REGULATOR TO REDUCE PRESSURE BACK TO ORIGINAL PRESSURE EXCEPT FOR PIPING SERVING AREA A AND C.
- M25 EXISTING GAS PIPING TO REMAIN.
- M26 PROVIDE GAS REGULATORS AT WATER HEATER SERVING AREA A AND C AND ROUTE VENT PIPING OUTDOORS. PRESSURE REGULATORS TO BE SET WITH INLET PRESSURE @ 2PSI AND OUTLET PRESSURE @ 7-14"WC.
- M27 EXISTING UNDERGROUND GAS PIPING TO REMAIN.
- M28 POINT OF CONNECTION FOR NEW GAS PIPING.

